


ROOF LINE (14FT)

16.000"  
CLASS A  
PIPING

35 KILO ROASTER AND COOLER PIPING LAYOUT

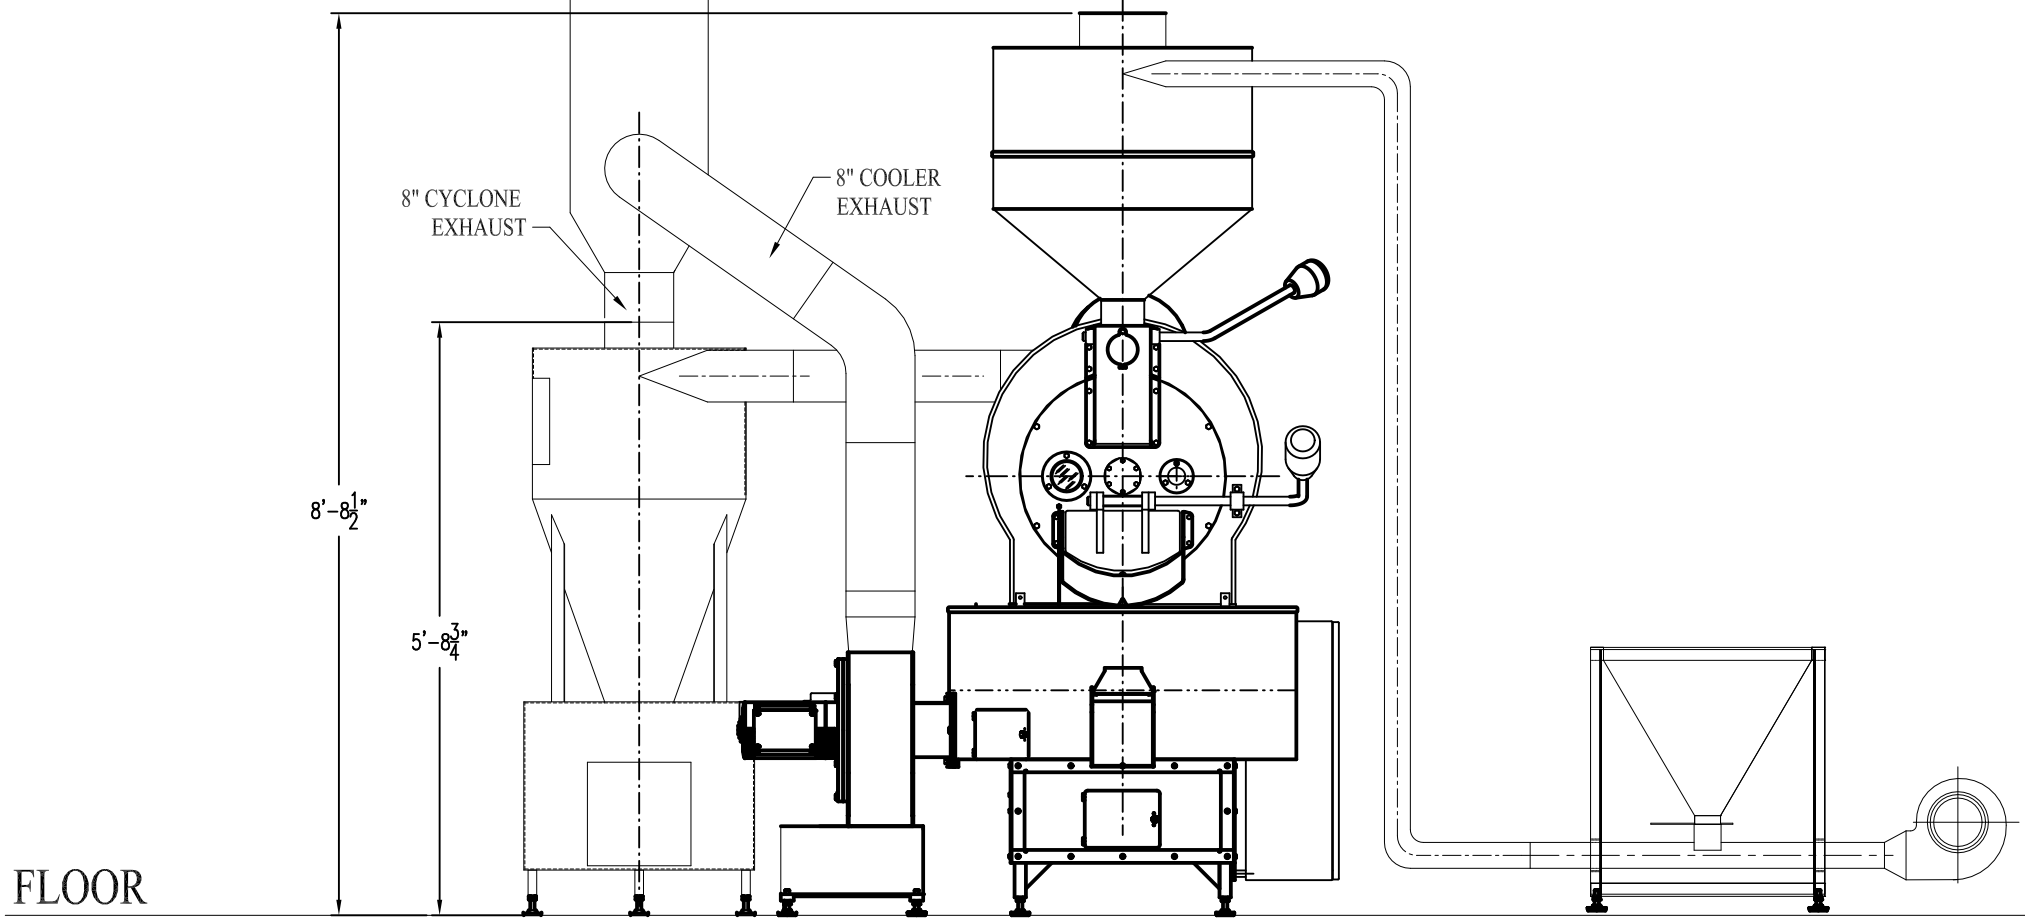

FLOOR

8'-8 1/2"

5'-8 3/4"

This drawing is property of Roasters Exchange (U.S. Roaster Corp) and is intended for the sole use of the intended recipient(s). If you are not an intended recipient you should not read, copy, disclose, circulate or in any other way use this information. The information contained in this transmission may be confidential and /or privileged. If you have received this transmission in error, please notify the sender immediately and delete this transmission, including any attachments.

			TOLERANCES: UNLESS OTHERWISE NOTED			Roasters Exchange 1530 West Main Oklahoma City, Ok 73106	DRN.BY RLS	DATE 08/25/08	TITLE
			DECIMAL	FRACTIONAL	ANGULAR		CKD.BY	DATE	35 KILO ROASTER ASSEMBLY DRAWING
			2 PL. ±.015	±1/32"	± 1%	APPD.BY	DATE	DRAWING NO.	
A	NEW DRAWING	RLS 08/25/08	3 PL. ±.005						SCALE NONE
LET	REVISION	SIG. - DATE							